



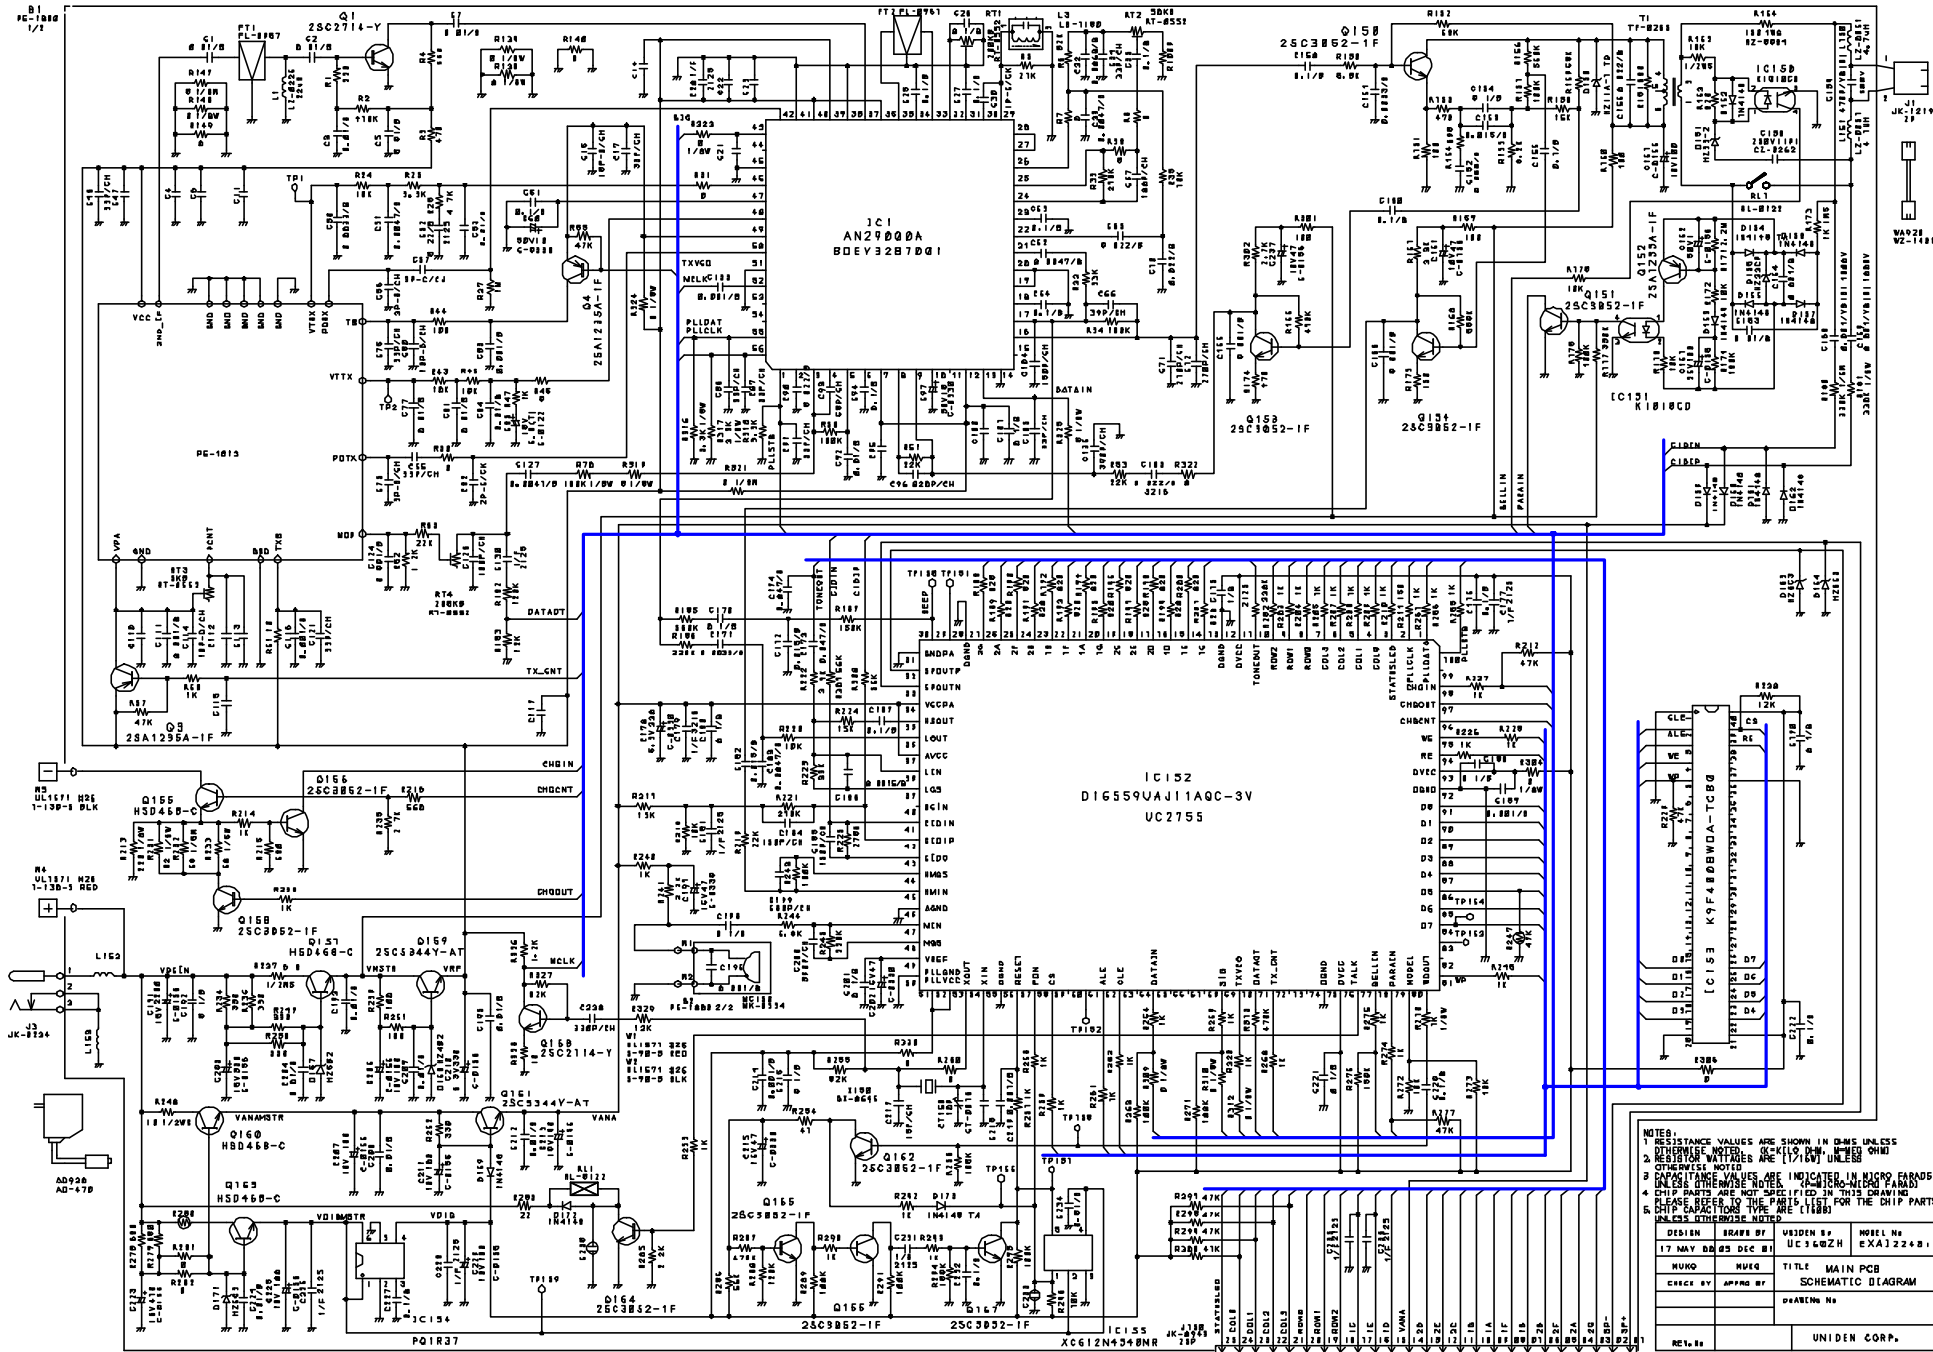

NOTES:

1. RESISTANCE VALUES ARE SHOWN IN OHMS UNLESS OTHERWISE NOTED.
2. CAPACITANCE VALUES ARE IN PICO-FARADS UNLESS OTHERWISE NOTED.
3. DIMENSIONS ARE IN MILLIMETERS UNLESS OTHERWISE NOTED.
4. DIMENSIONS ARE IN INCHES UNLESS OTHERWISE NOTED.
5. DIMENSIONS ARE IN MILLIMETERS UNLESS OTHERWISE NOTED.
6. DIMENSIONS ARE IN INCHES UNLESS OTHERWISE NOTED.


DESIGN	DATE	VERSION	MODEL
17 MAY 88	DEC 81	UC3602H	EXA1224.81
TITLE: MAIN PCB SCHEMATIC DIAGRAM			
DRAWING NO.			
UNIDEN CORP.			

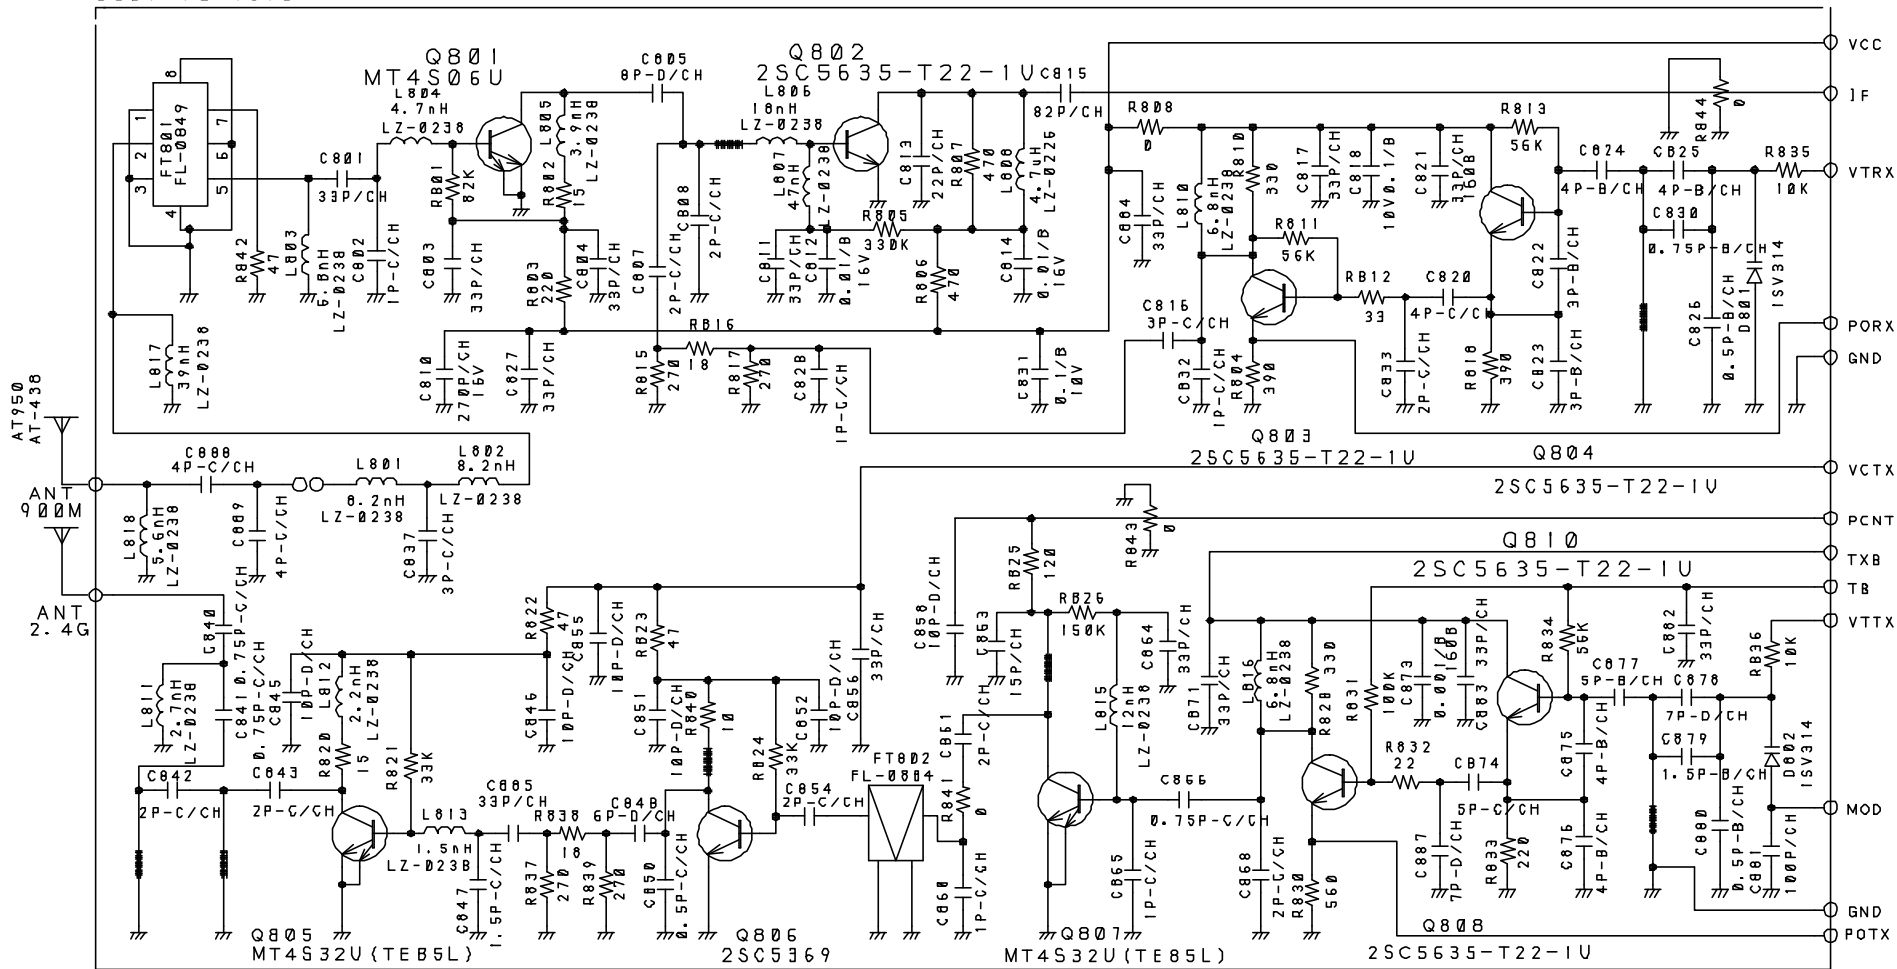

NOTES:

1. RESISTANCE VALUES ARE SHOWN IN OHMS UNLESS OTHERWISE NOTED. (K=KILO OHM, M=MEG OHM)
2. RESISTOR WATTAGES ARE [1/16W (1005)] UNLESS OTHERWISE NOTED.
3. CAPACITANCE VALUES ARE INDICATED IN MICRO FARADS UNLESS OTHERWISE NOTED. (P=MICRO-MICRO FARAD)
4. CHIP PARTS ARE NOT SPECIFIED IN THIS DRAWING PLEASE REFER TO THE PARTS LIST FOR THE CHIP PARTS.
5. CHIP CAPACITORS TYPE ARE [1005] UNLESS OTHERWISE NOTED.

DESIGN	DRAWN BY	UNIDEN No.	MODEL No.
May/14/01	01/12/05	UC360ZH	EXA12248i
YUI	SUWA	TITLE BASE RF SCHEMATIC DIAGRAM	
CHECK BY	APPRO. BY		
		DRAWING No	
REV No		UNIDEN CORP.	

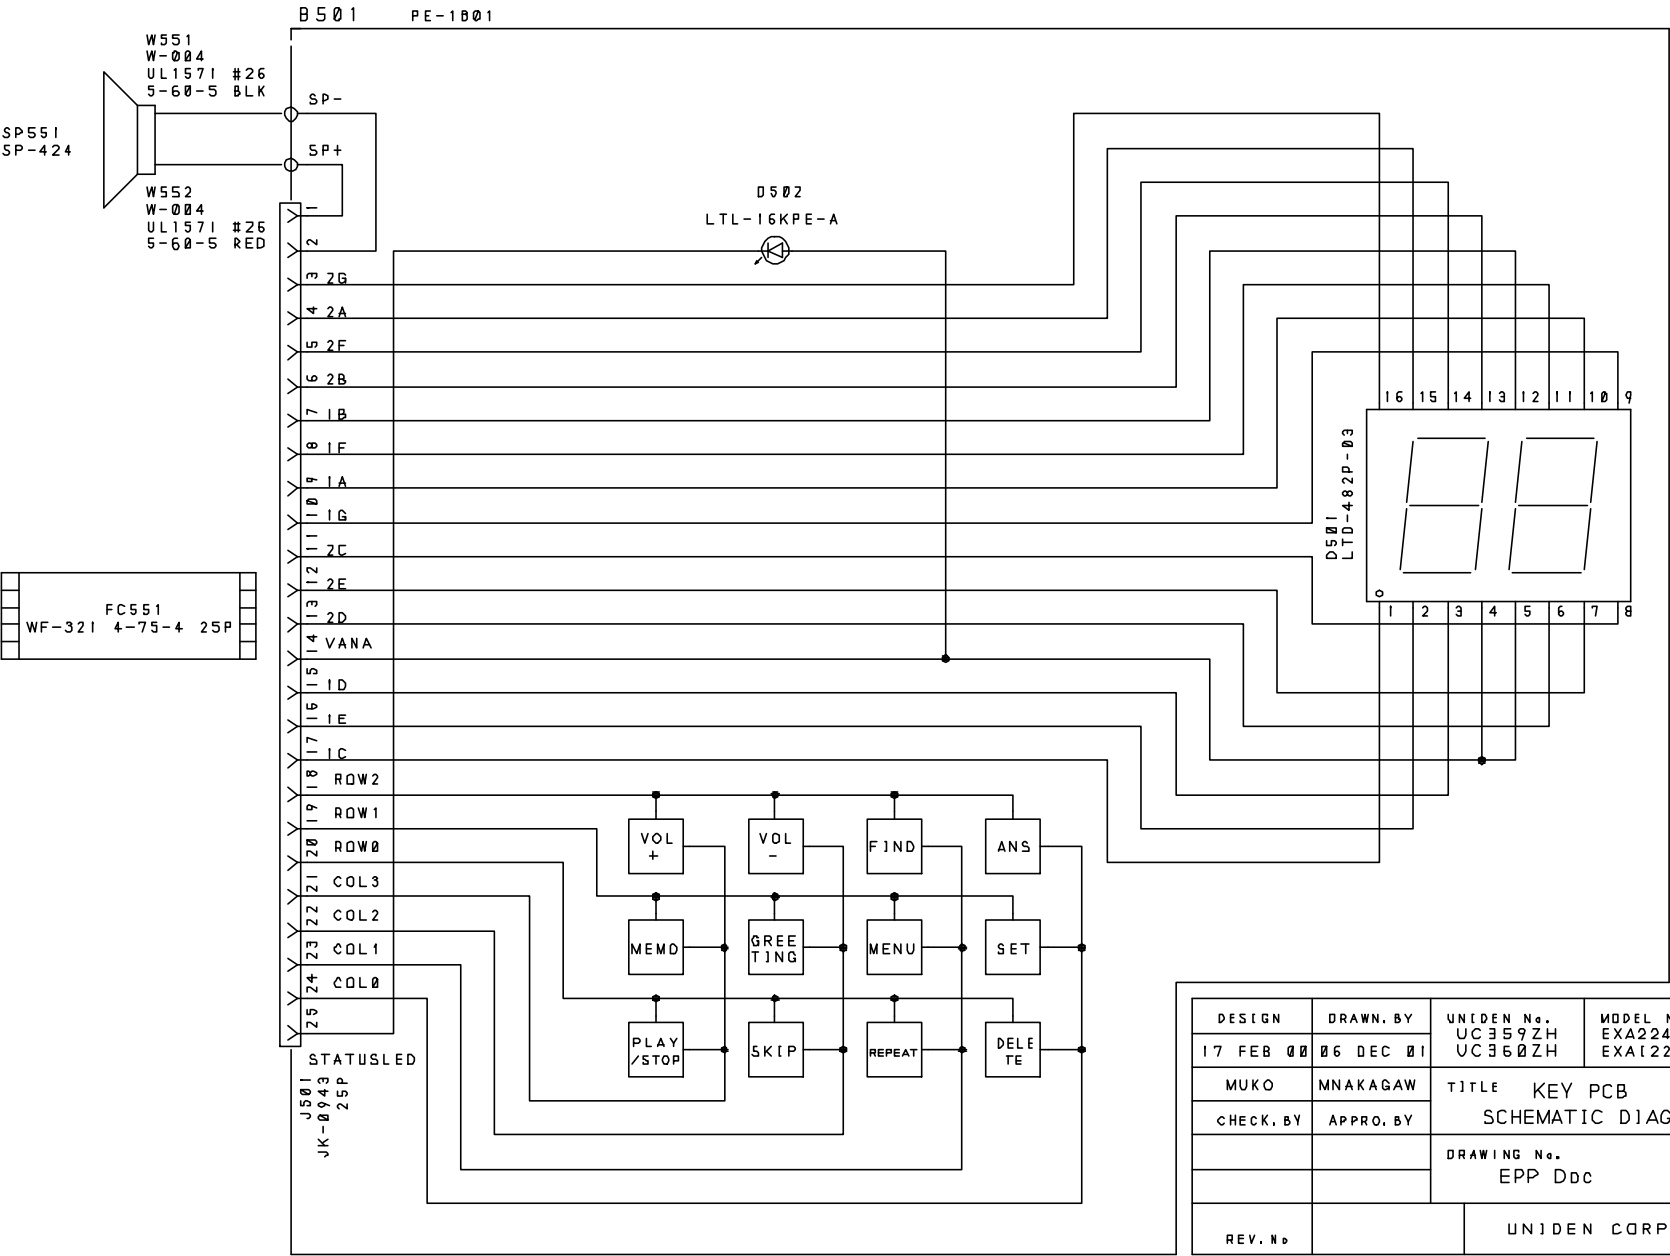

DESIGN	DRAWN BY	UNIDEN No.	MODEL No.
17 FEB 00	06 DEC 01	UC359ZH UC360ZH	EXA2245 EXA122401
MUKO	MNAKAGAW	TITLE KEY PCB SCHEMATIC DIAGRAM	
CHECK BY	APPRO BY	DRAWING No. EPP Ddc	
REV. No.		UNIDEN CORP	