

Installed Only in 11M
Install Only CN1168 in ACCESS


J15
RJHS-4381

1 F_TPTX+
2 F_TPTX-
3 F_TPRX+
4 PLUS_48V
5 RETURN_48V
6 F_TPRX-
7 T_TIP-SET-DEFAULT_F
8 T_RING-LINK

L1C 1 4.7K
L1D 1 4.7K
L2C 1 4.7K
L2A 1 4.7K

GND1
GND2


SIGNALS EXIT TO
THE OUTDOOR UNIT

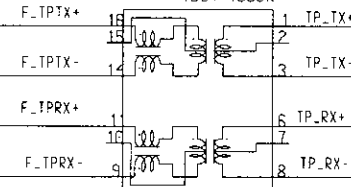

J12
RJ-45S

ETHERNET - ENTRY

Installed Only For ACCESS - Voice

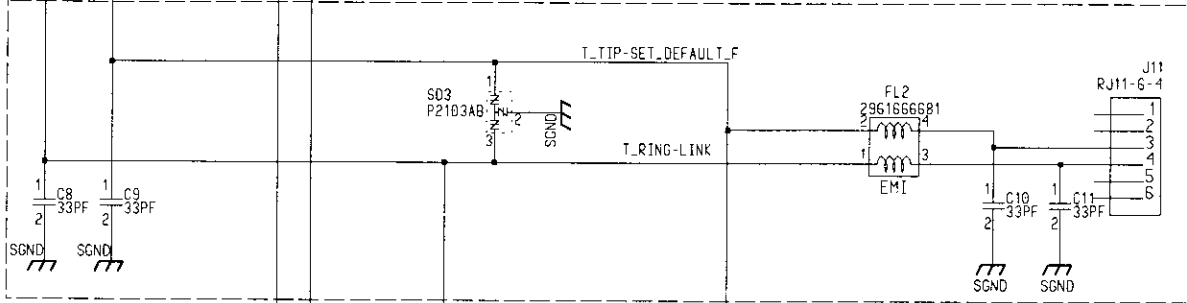


PHONE - ENTRY

Installed Only For 11M Indoor



RESET SWITCH

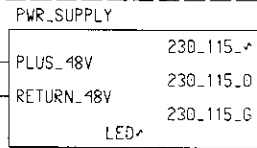

Power Indicator
D61
D62
RETURN_48V
LED_POWER


J16
Install fs1016 250mA for 230VAC
PF0001_PC
Install fs1017 500mA for 115VAC

POWER - ENTRY

Installed Only For Access

Engineer: Shay Ratsow		BreezeCOM Breeze Wireless Communication	
Drawn by: Shay Ratsow		TITLE: DS11M - INDOOR UNIT PC1059	
R&D CHK:		Size: A4	
DOC CTRL CHK:		S 1 4 A TL	
MFG CTRL CHK:		REV: 0	
QA CHK:		Drawing Number:	
Changed by:		Page: 1 of 2	


Date Changed:	Time:	REV:	Drawing Number:	Page:
---------------	-------	------	-----------------	-------

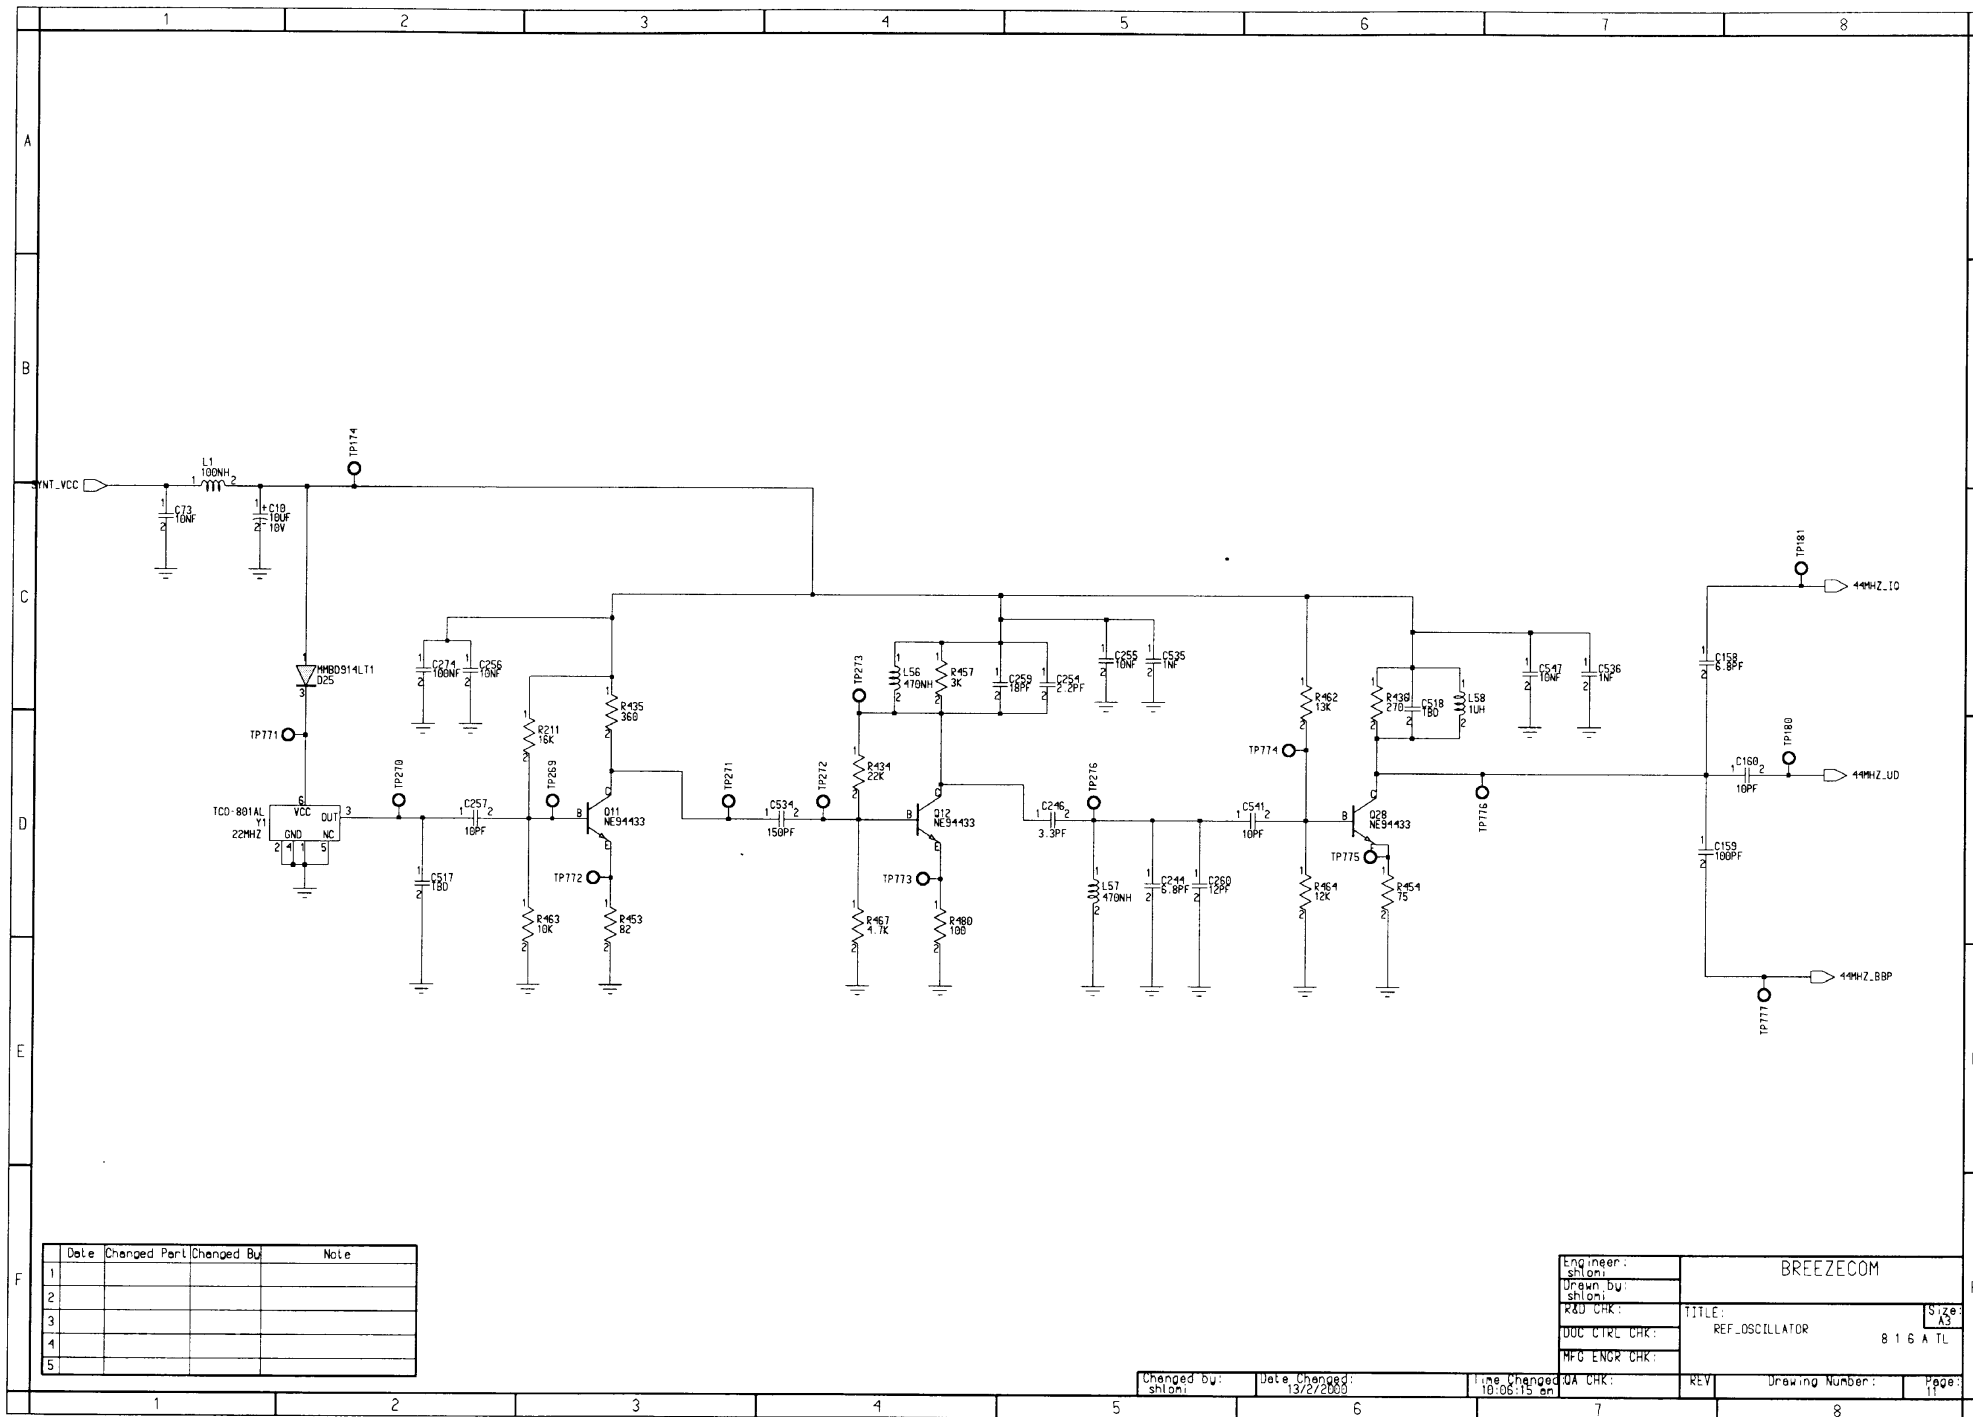


Date	Changed Part	Changed By	Note
1			
2			
3			
4			
5			

Engineer:	shlomi	BREEZECOM
Drawn by:	shlomi	
RD CHK:		
UDC CTRL CHK:		
MFG ENGR CHK:		
TITLE:	REF_OSCILLATOR	Size A3
REV		8 1 6 A TL
Drawing Number:		Page:

Changed by: shlomi Date Changed: 13/2/2009 Time Changed: 10:06:15 on

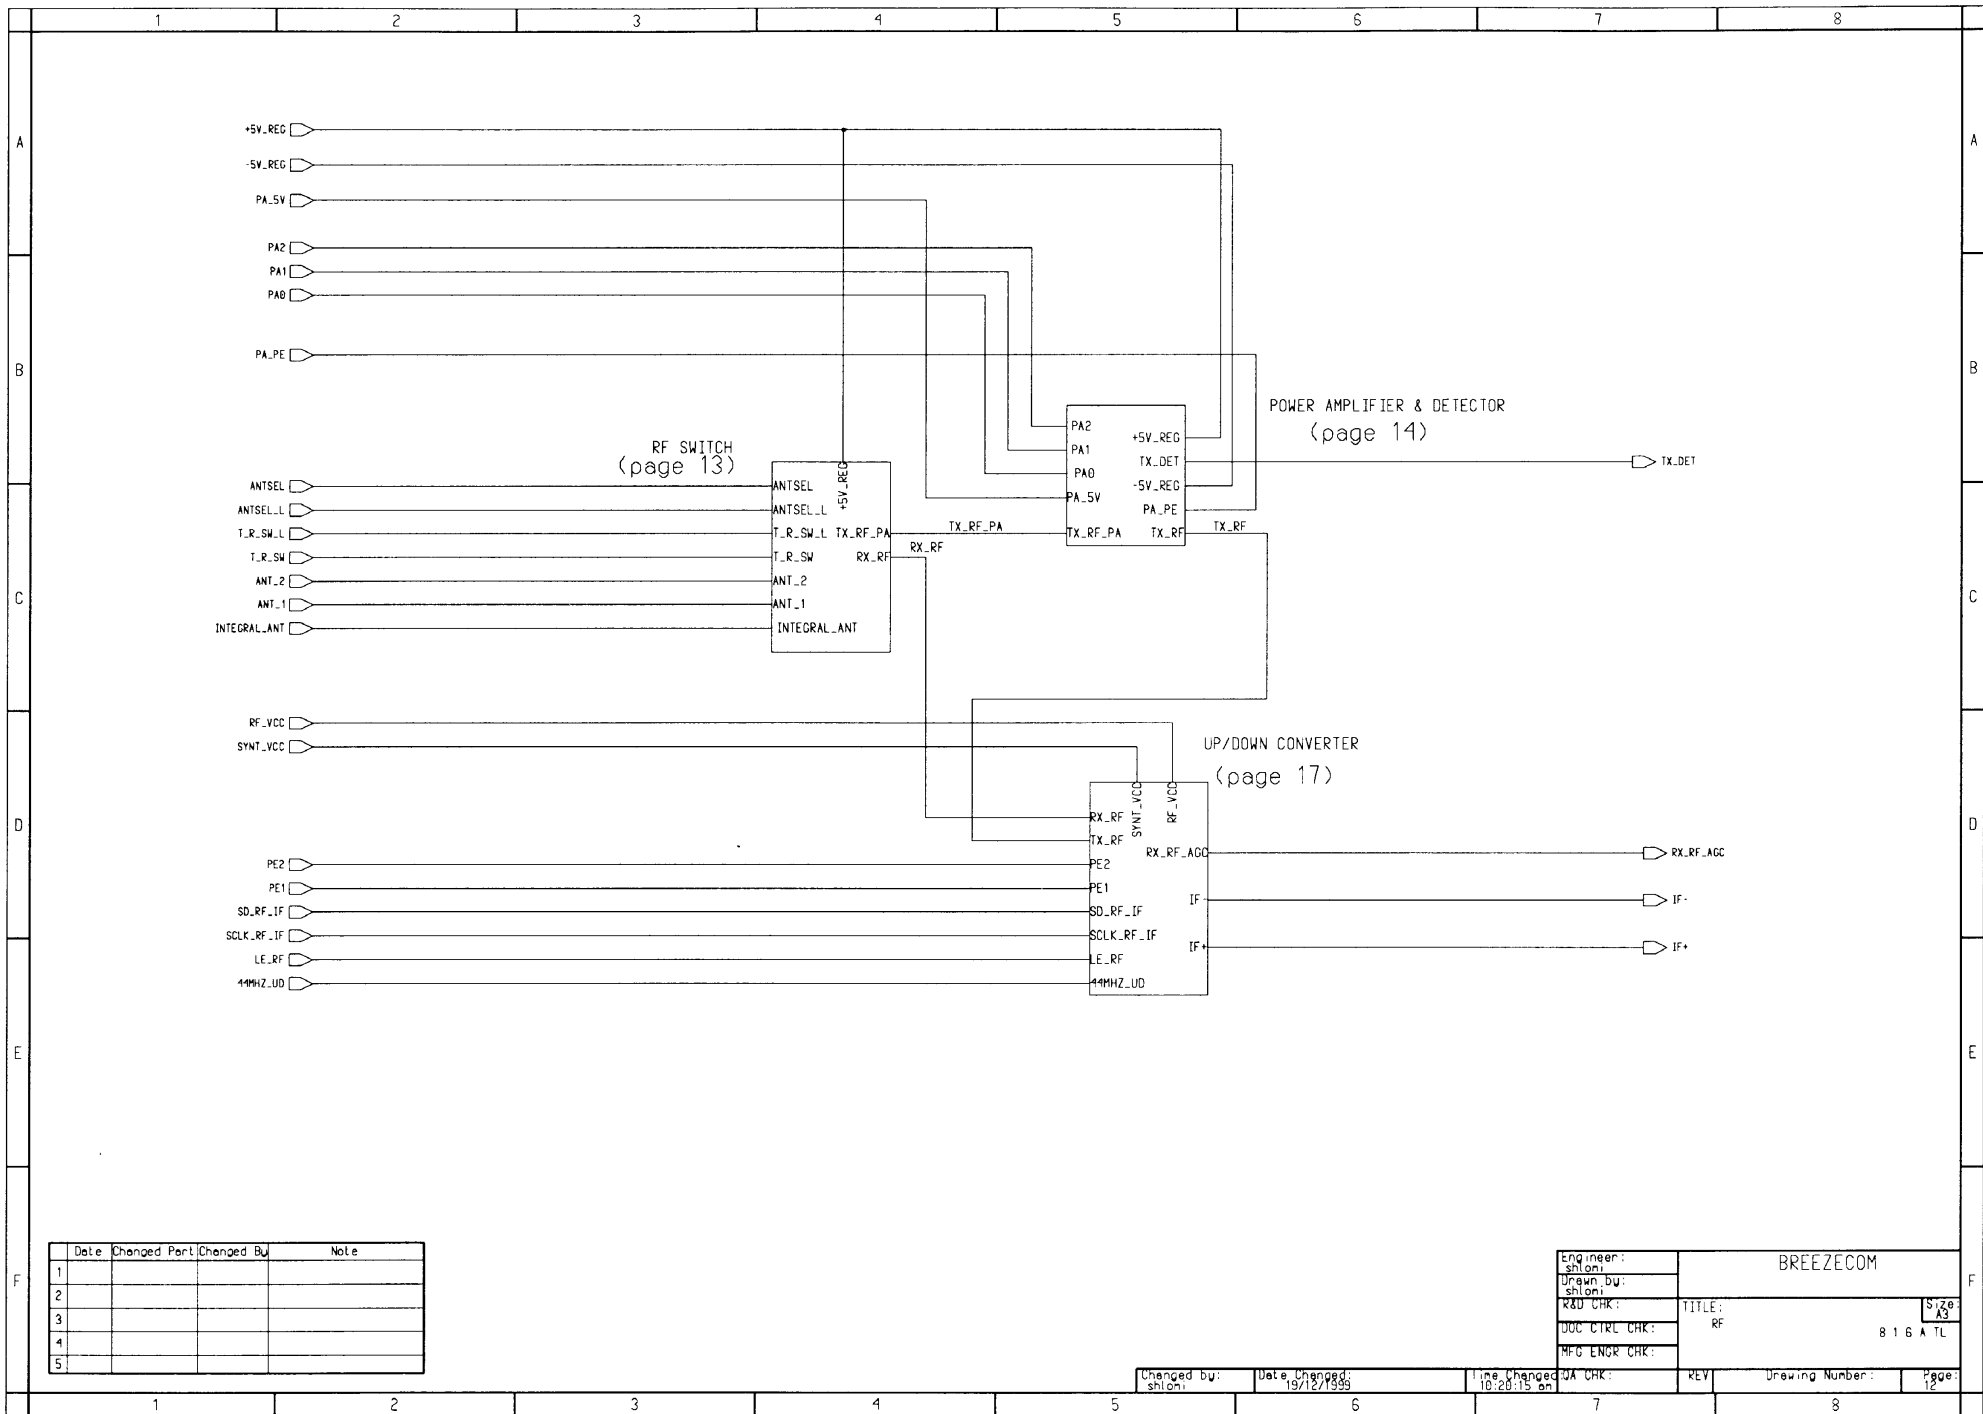


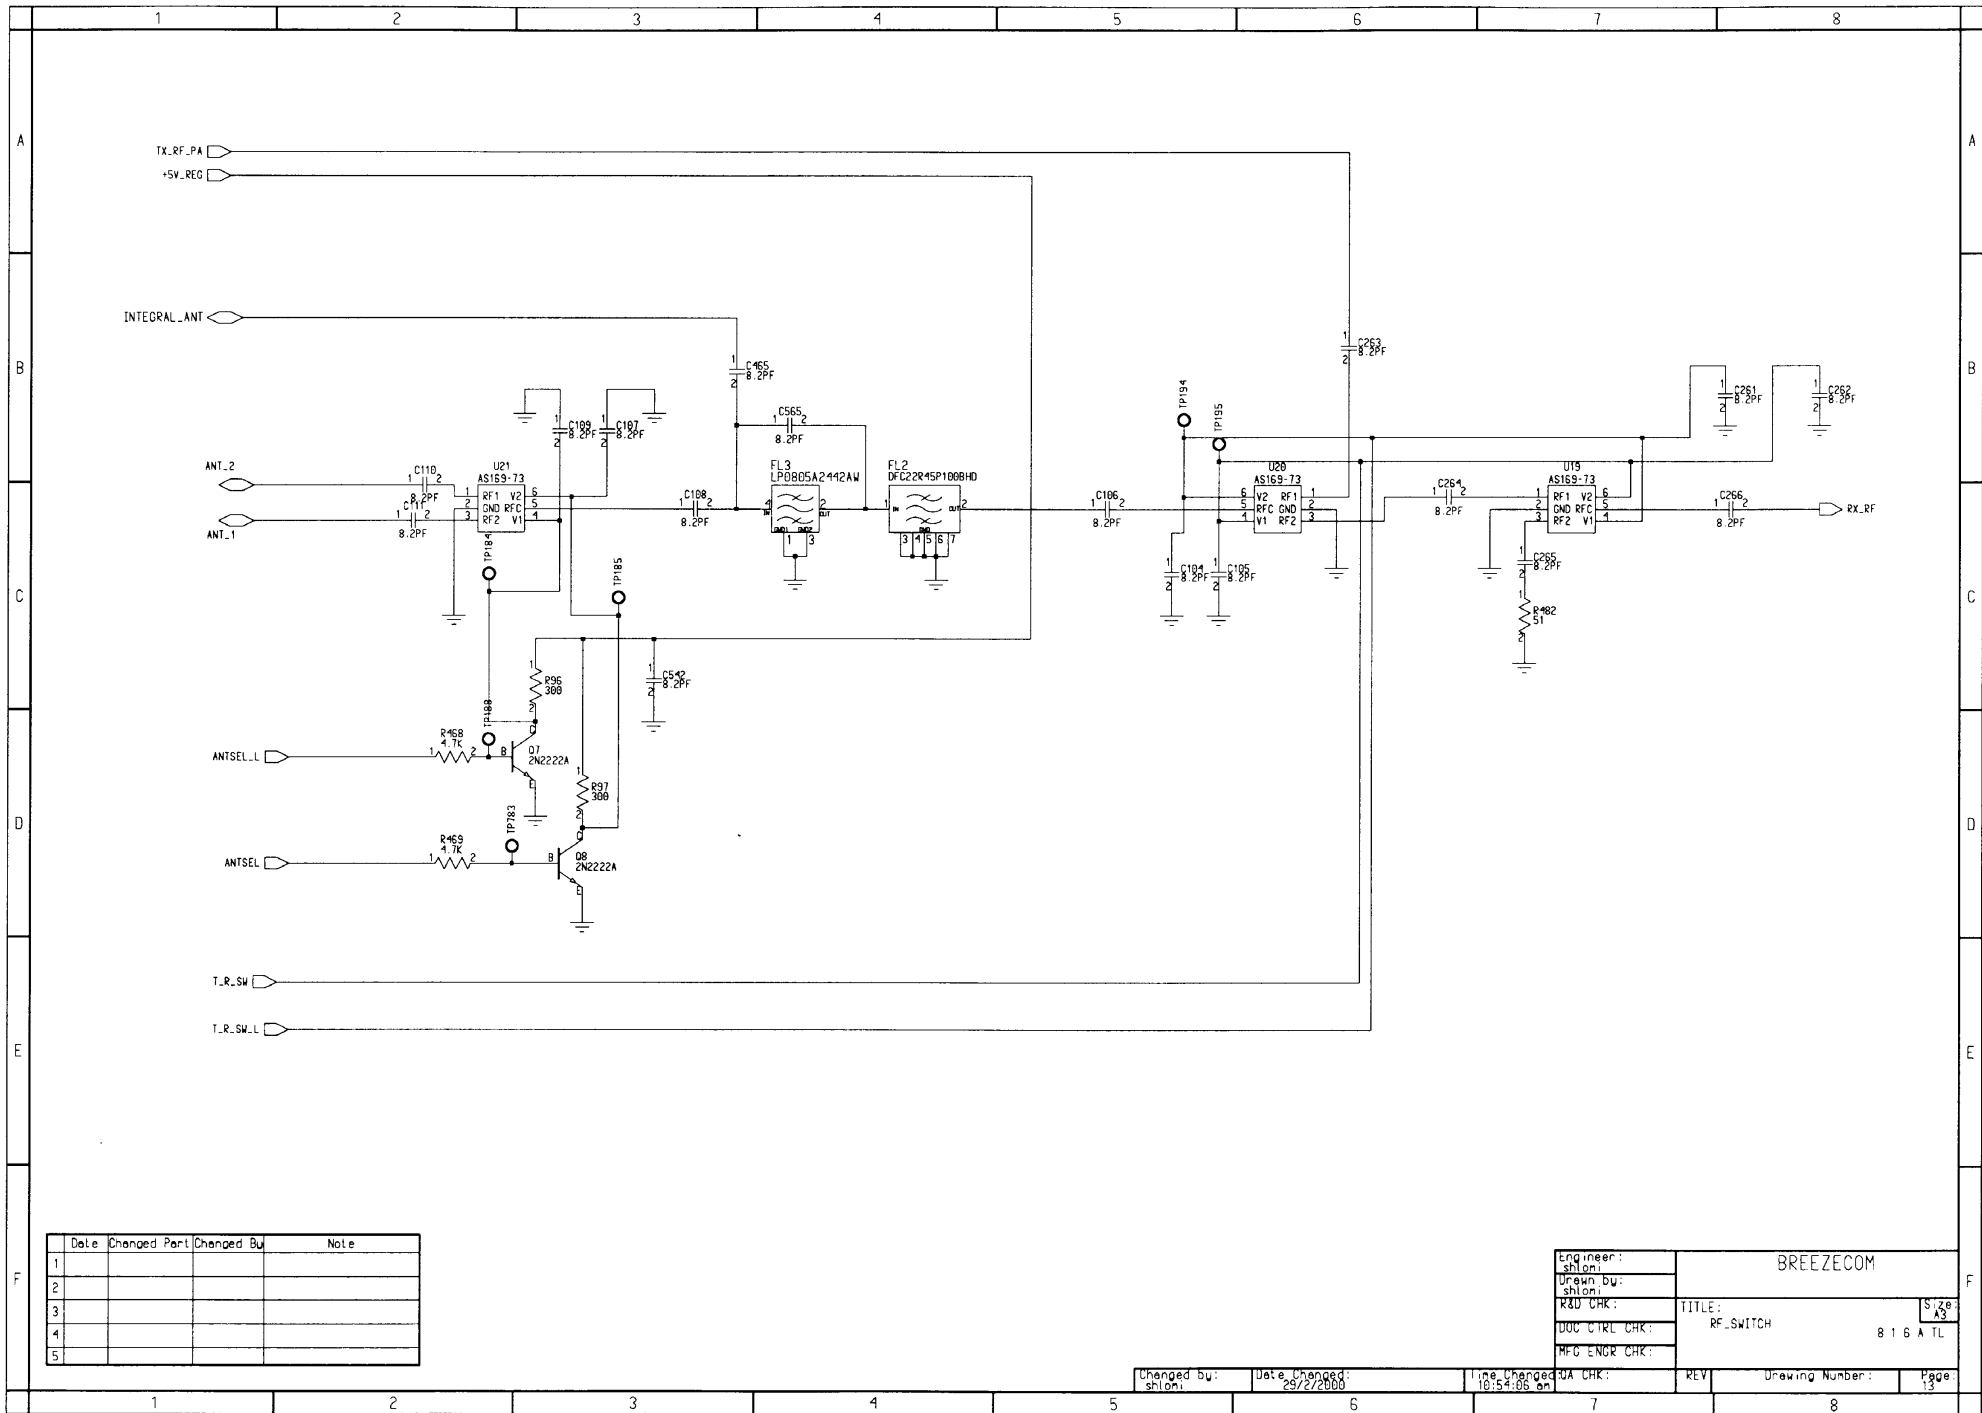



	Date	Changed Part	Changed By	Note
1				
2				
3				
4				
5				

Engineer:	shloni	BREEZECOM
Drawn by:	shloni	
R&D CHK:		
DOC CTRL CHK:		
MFG ENGR CHK:		
TITLE:	RF_SWITCH	Size A3
		816 A TL

Changed by:	Date Changed:	Time Changed:	Rev	Drawing Number:	Page
shloni	29/2/2000	10:54:05 am			13

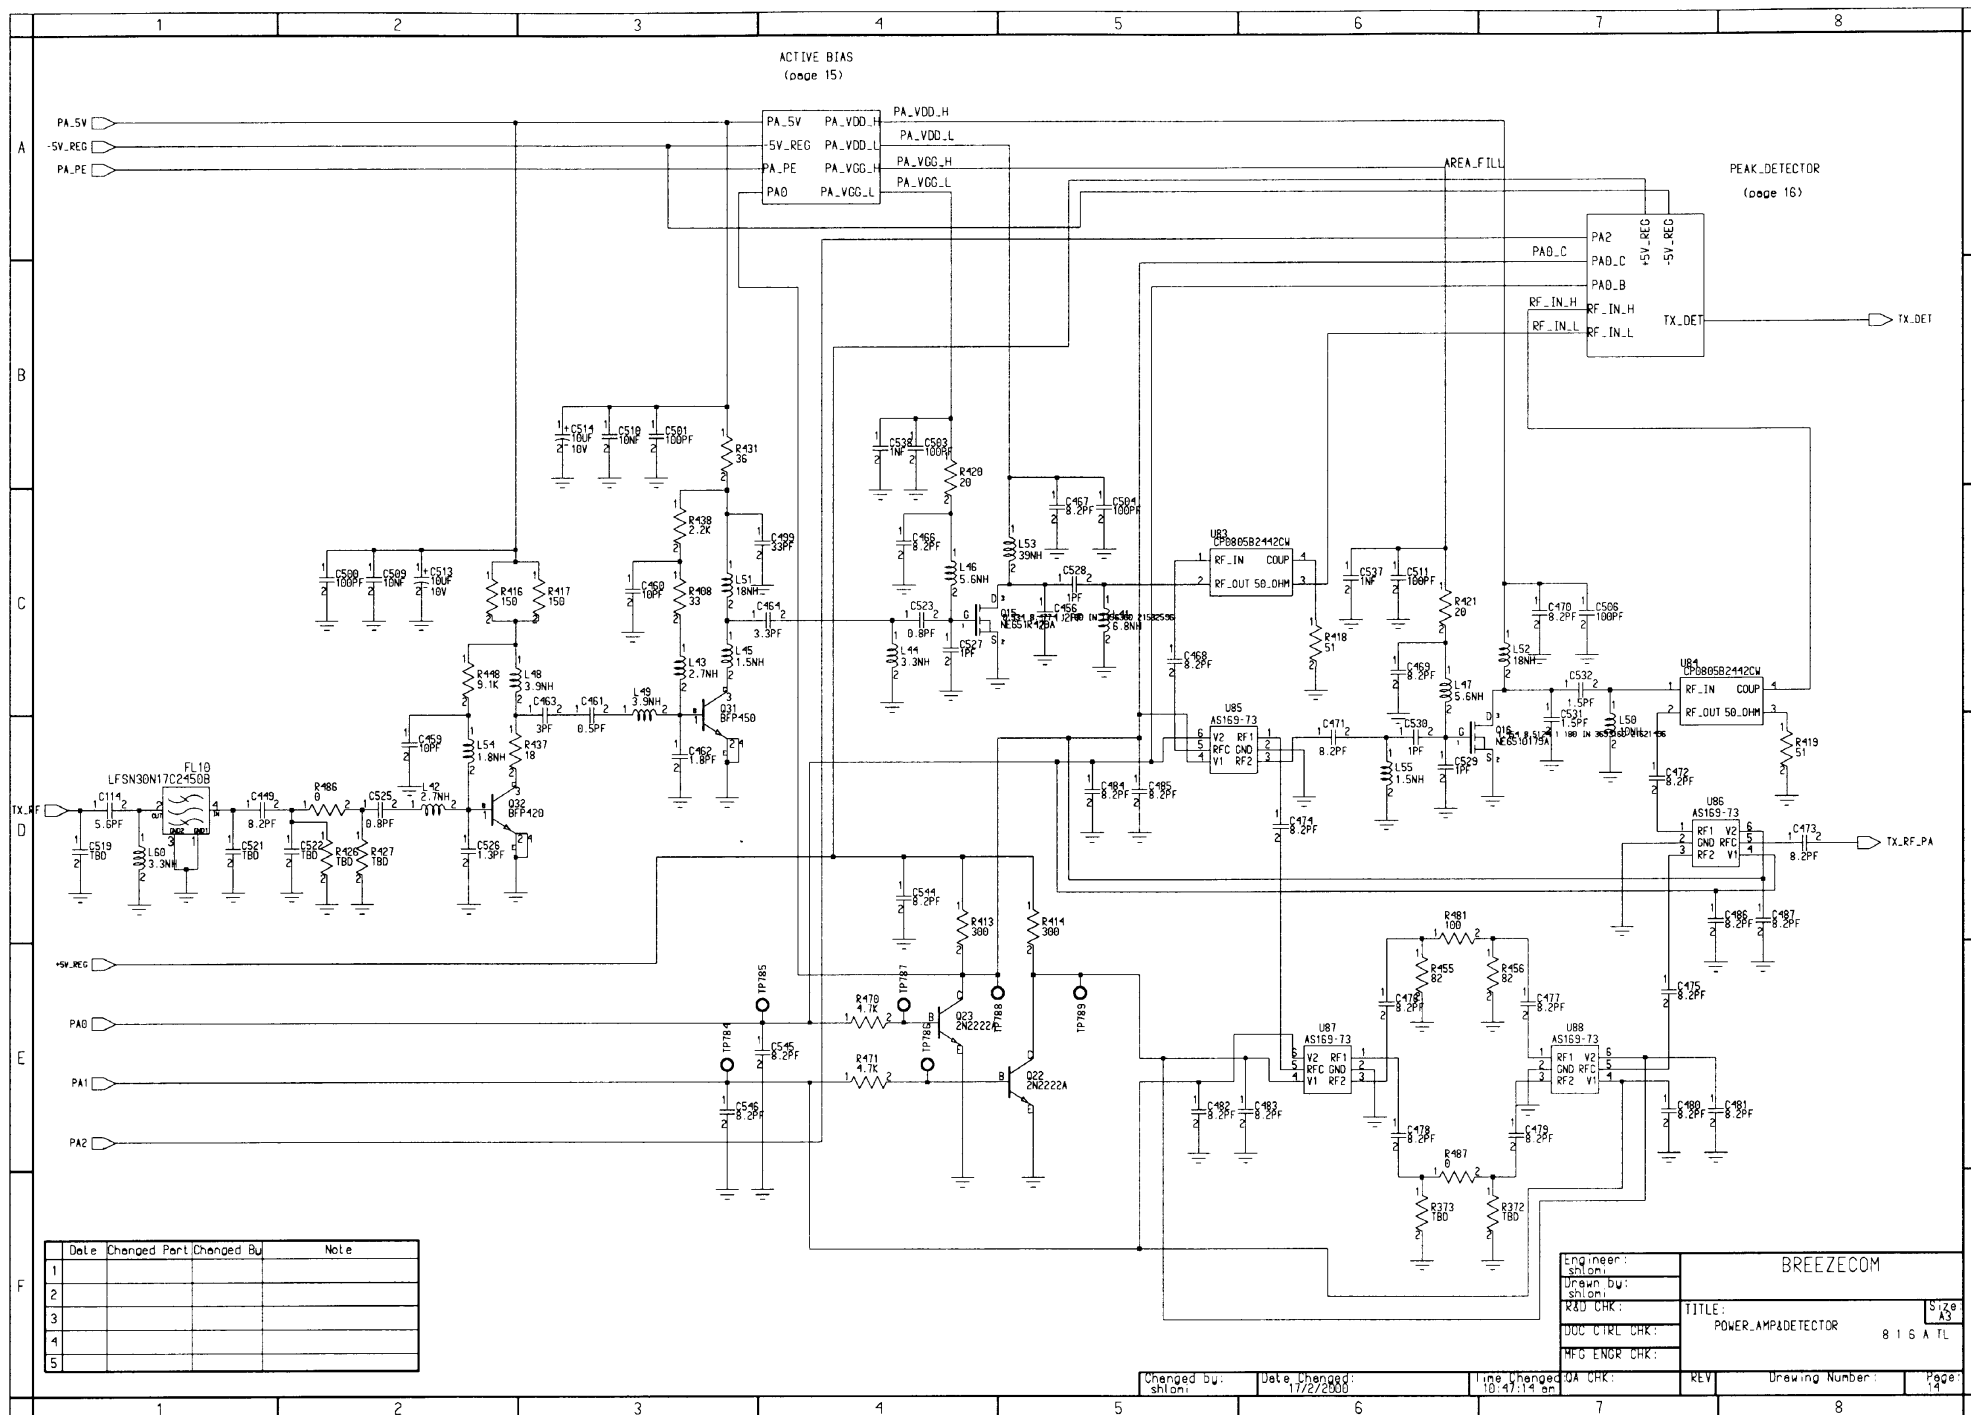


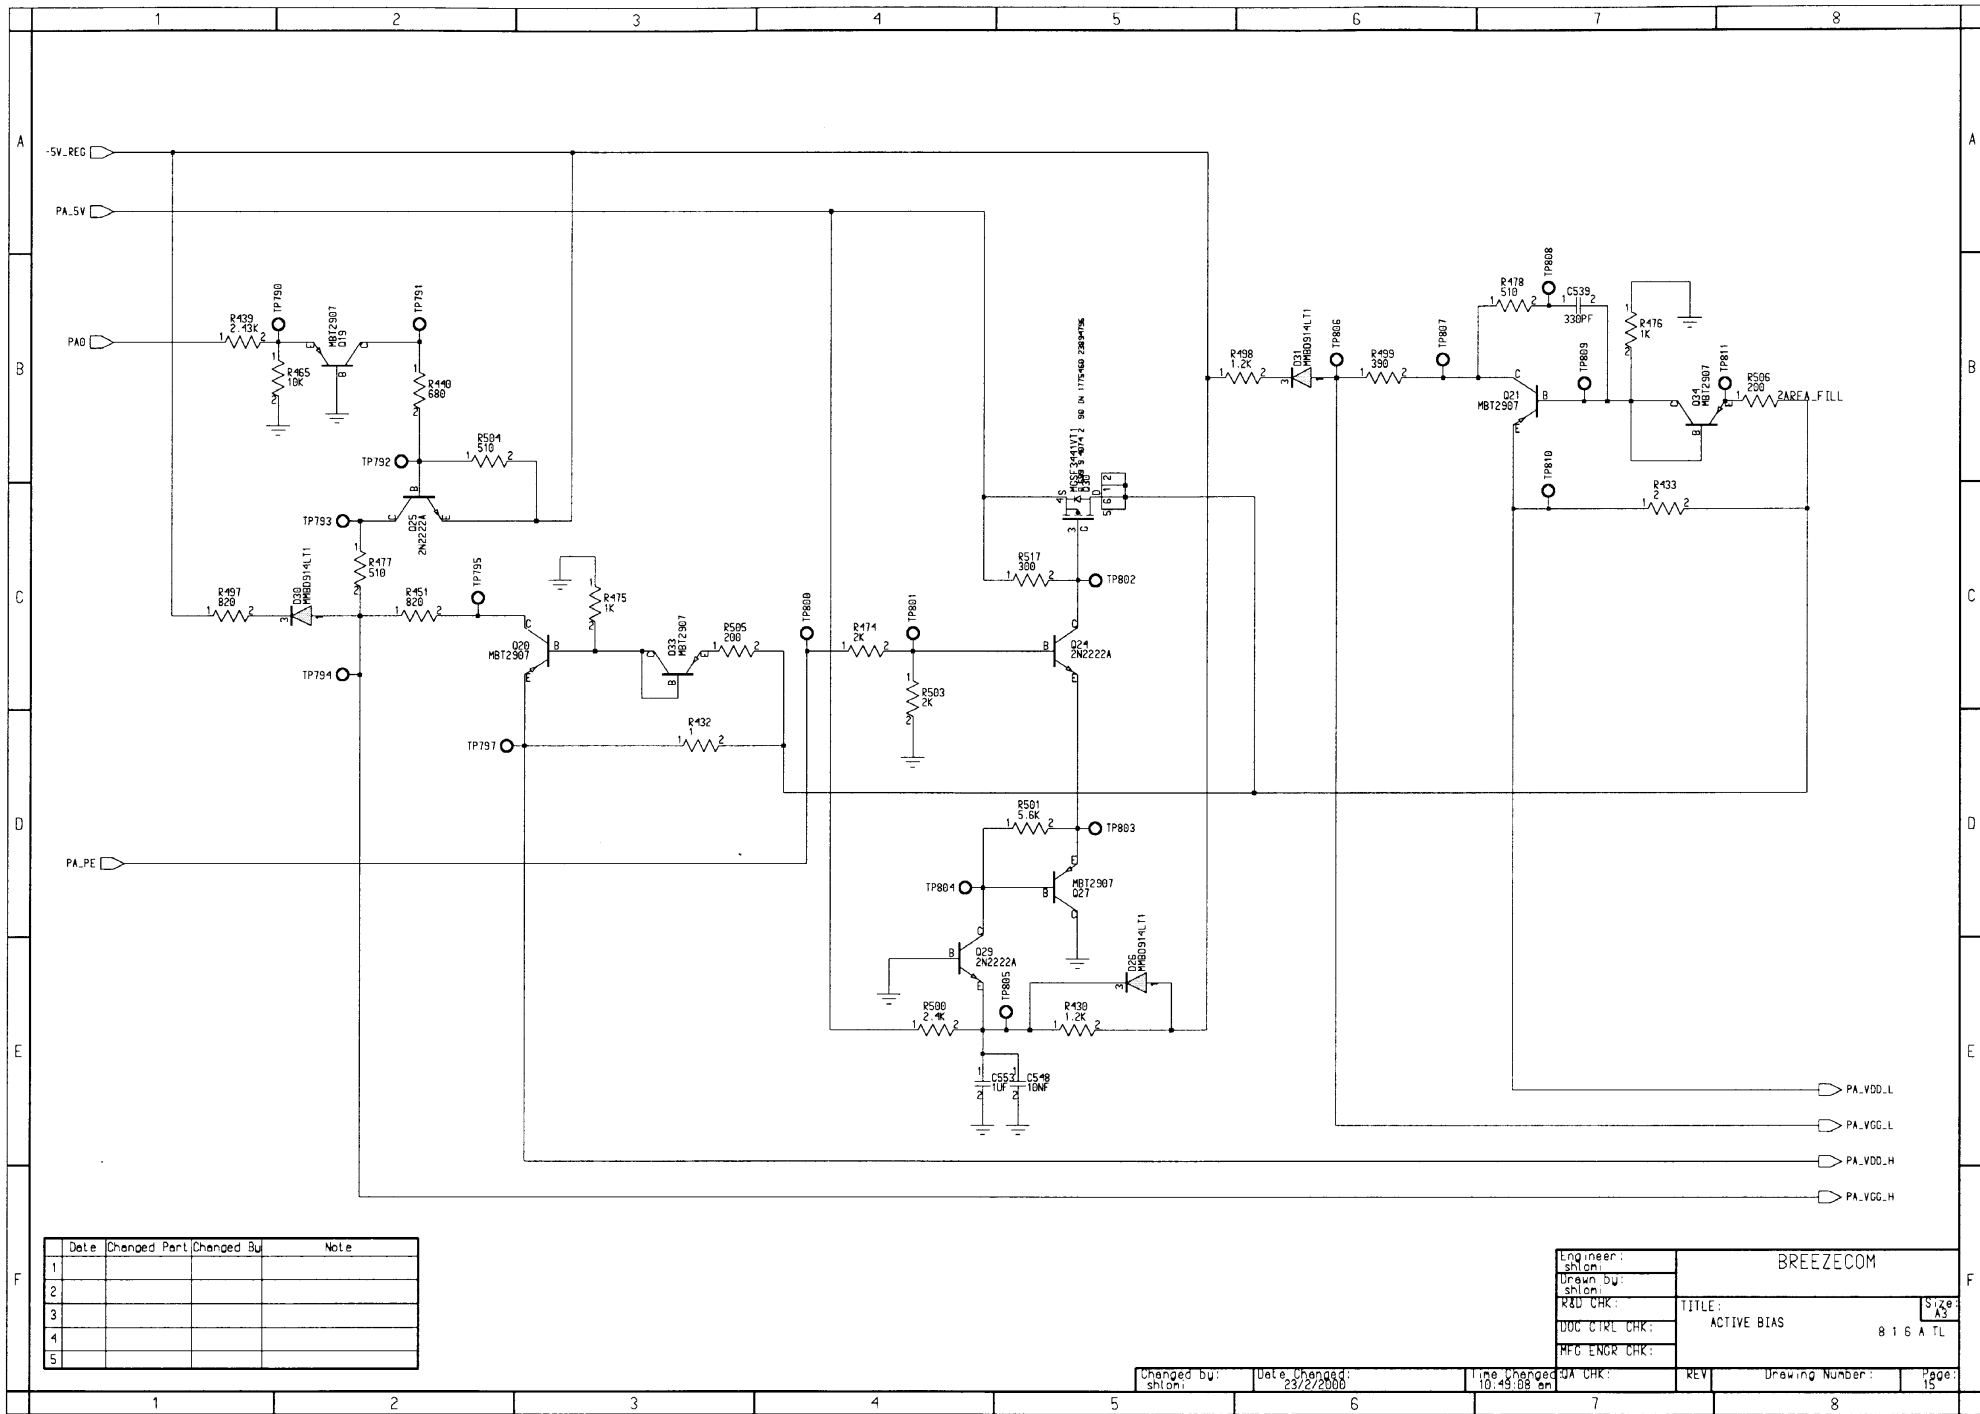


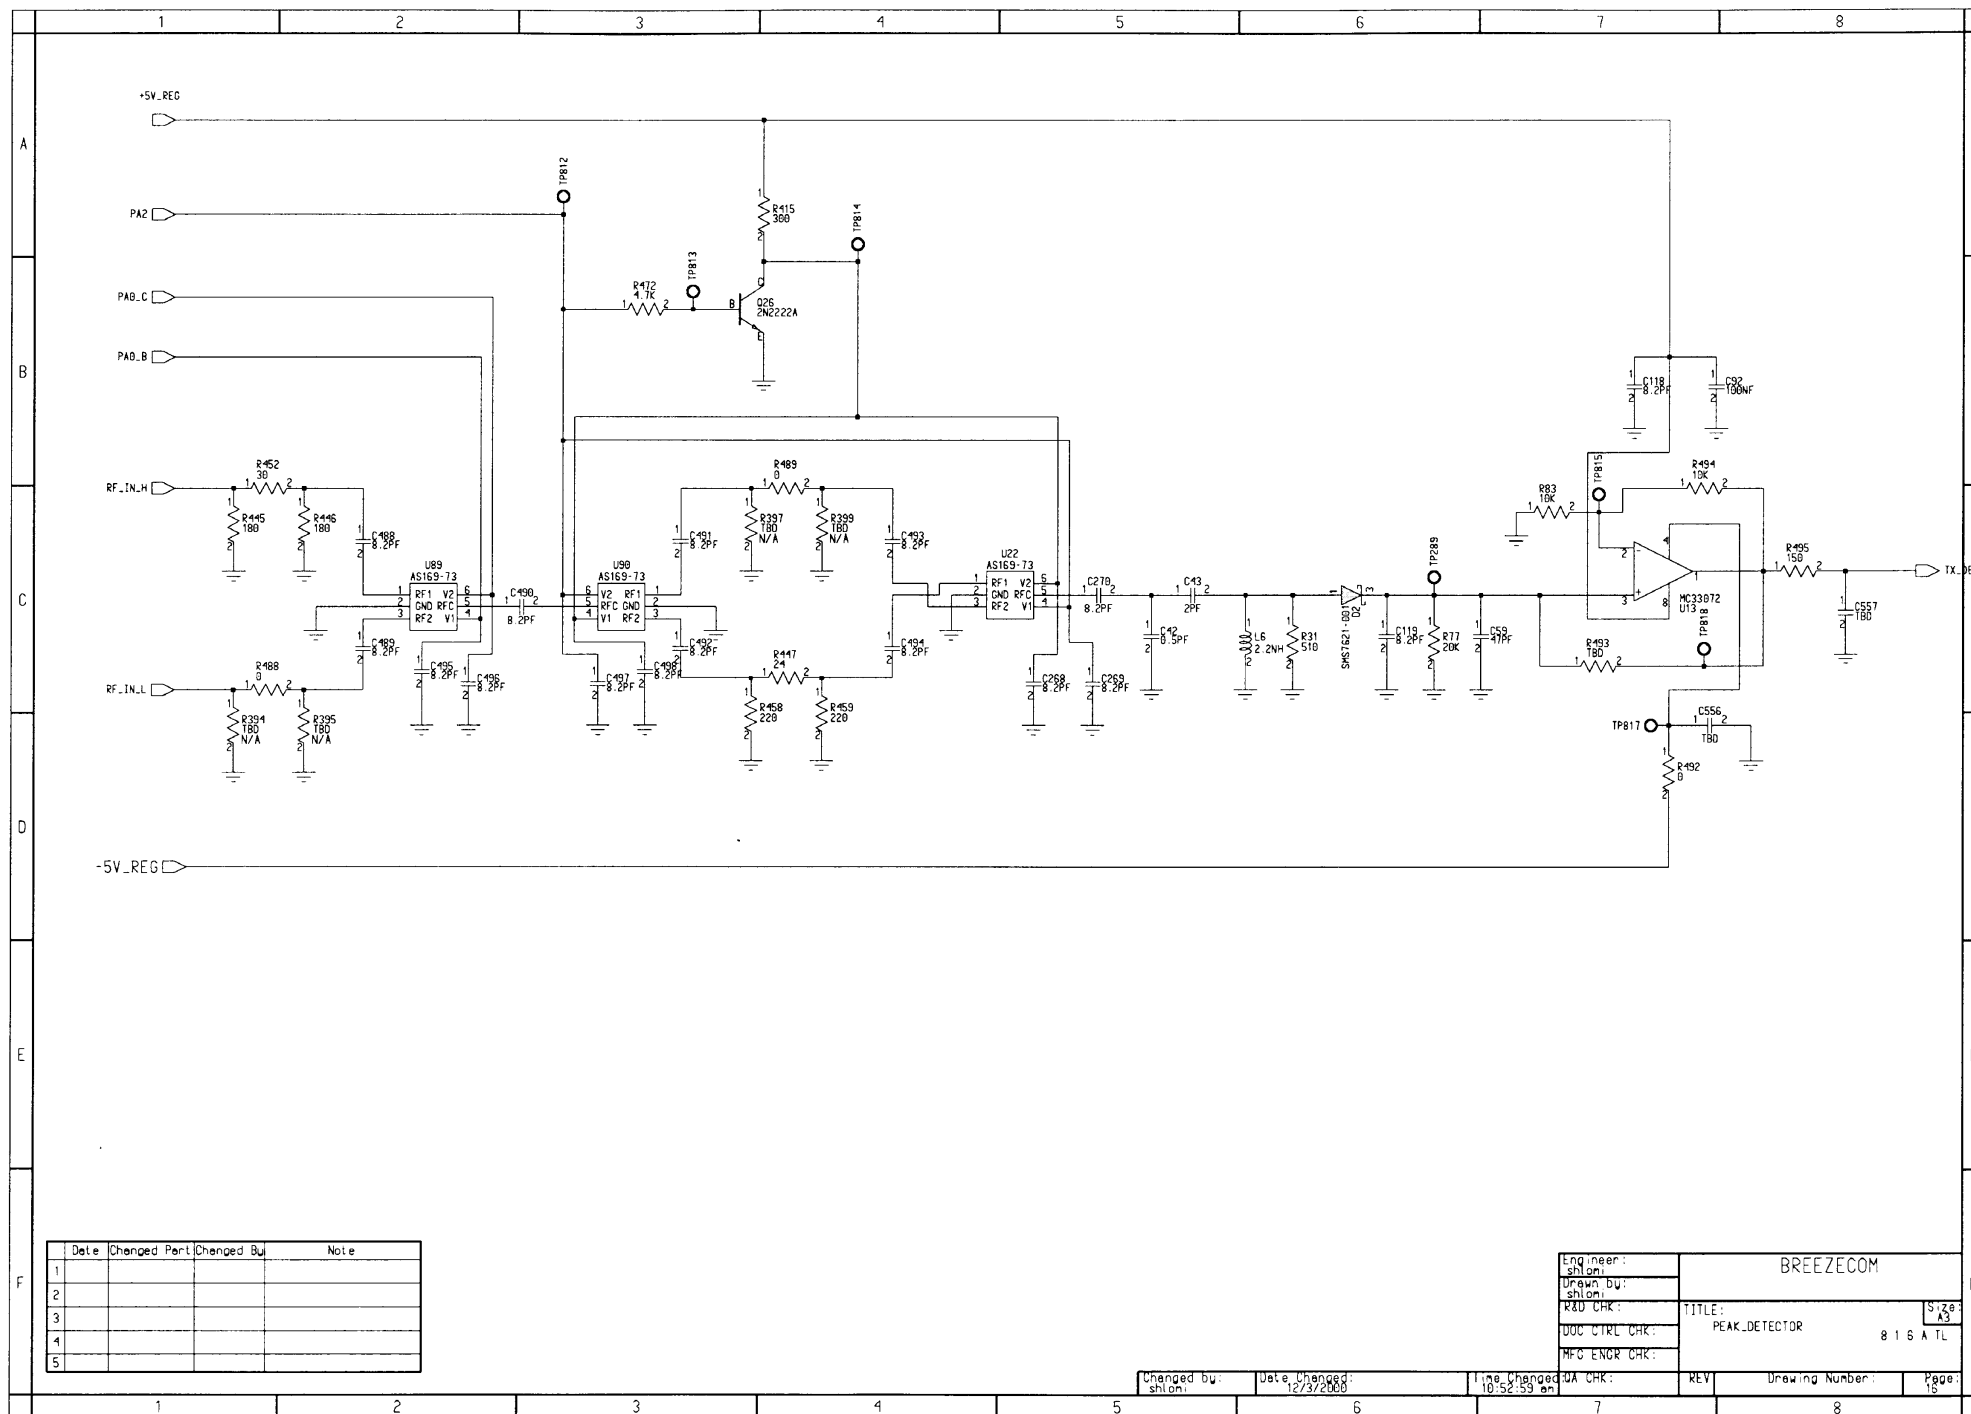

Date	Changed Part	Changed By	Note
1			
2			
3			
4			
5			


Engineer:	shloni	BREEZECOM	
Drawn by:	shloni		
R&D CHK:		TITLE:	PEAK_DETECTOR
DOC CTRL CHK:			816 A TL
MFG ENGR CHK:			
Chg'd by:	shloni	Date:	12/3/2000
Time:	10:52:59 am	Rev:	1
Chg'd by:	shloni	Date:	12/3/2000
Time:	10:52:59 am	Rev:	1

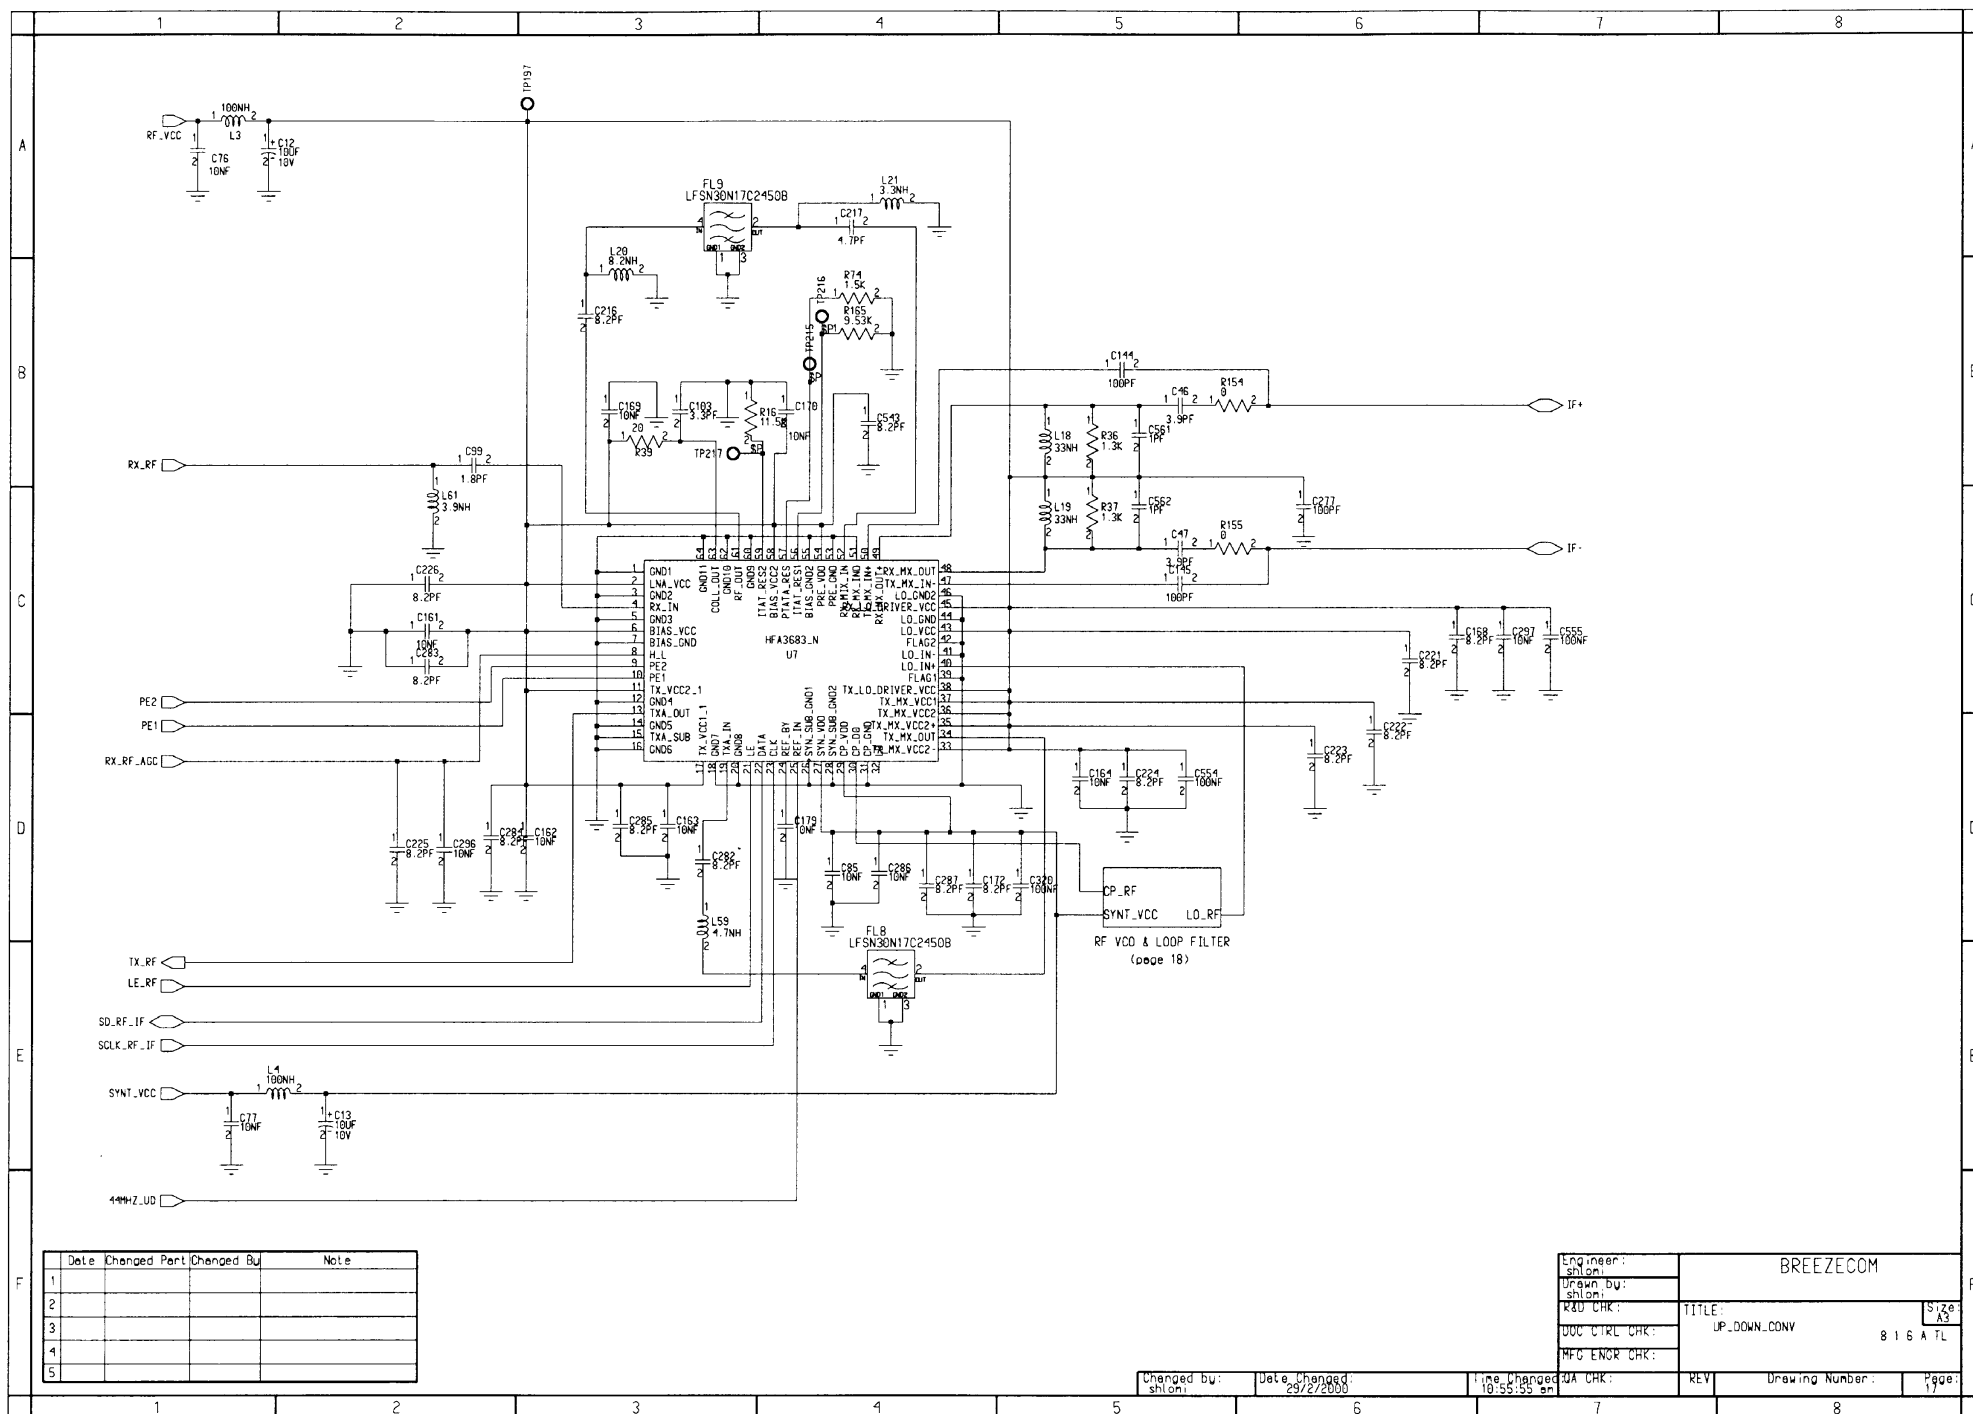


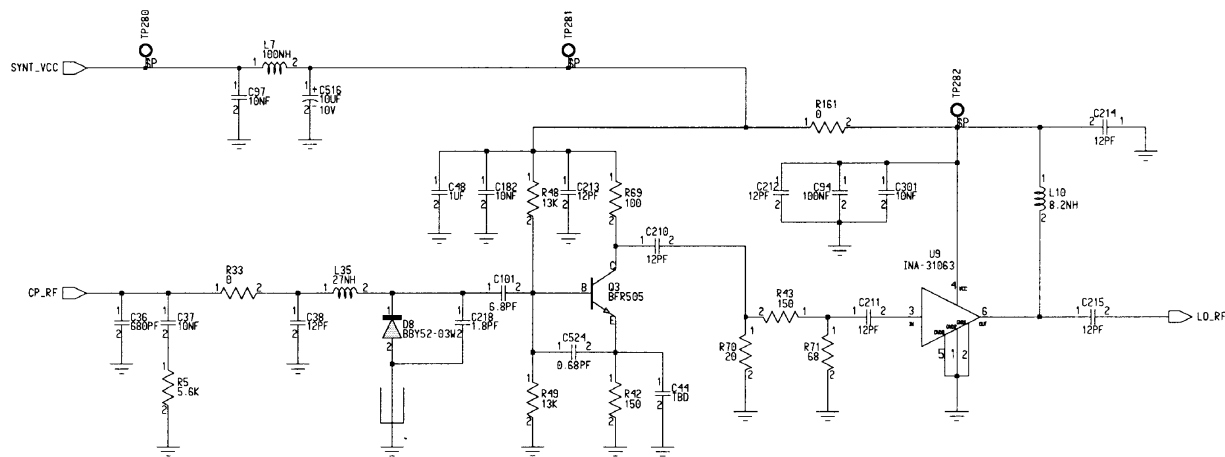

Date	Changed Part	Changed By	Note
1			
2			
3			
4			
5			

Engineer:	shloni	BREEZECOM	
Drawn by:	shloni		
REV	CHK	TITLE:	RF_VCO
DOC CTRL	CHK		8 1 6 A TL
MFG ENGR	CHK		
Changed by:	Date Changed:	Time Changed:	Page:
shloni	23/2/2000	11:03:47 am	18

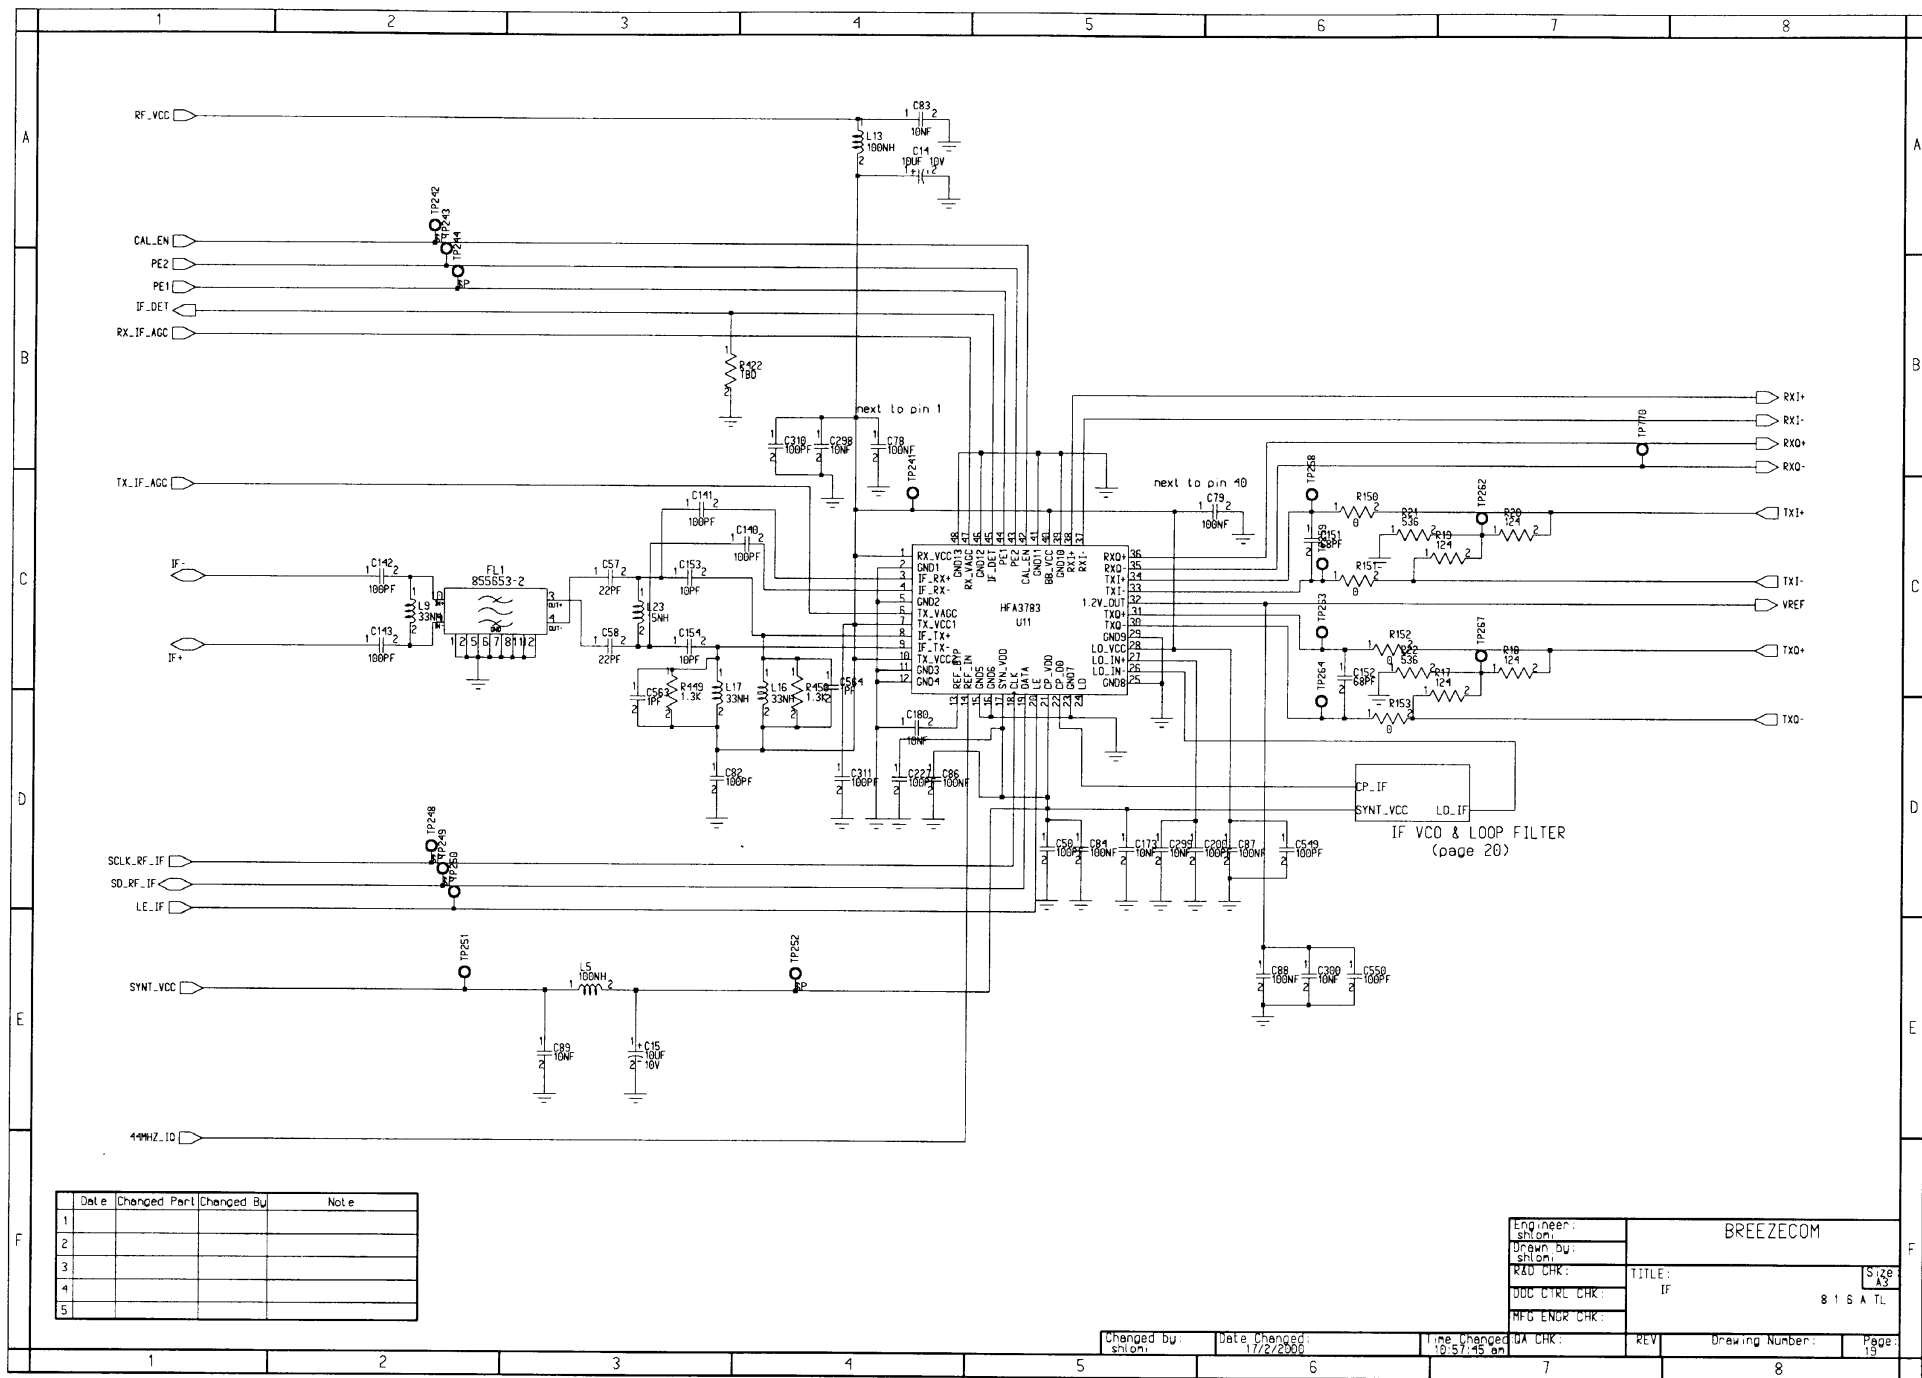

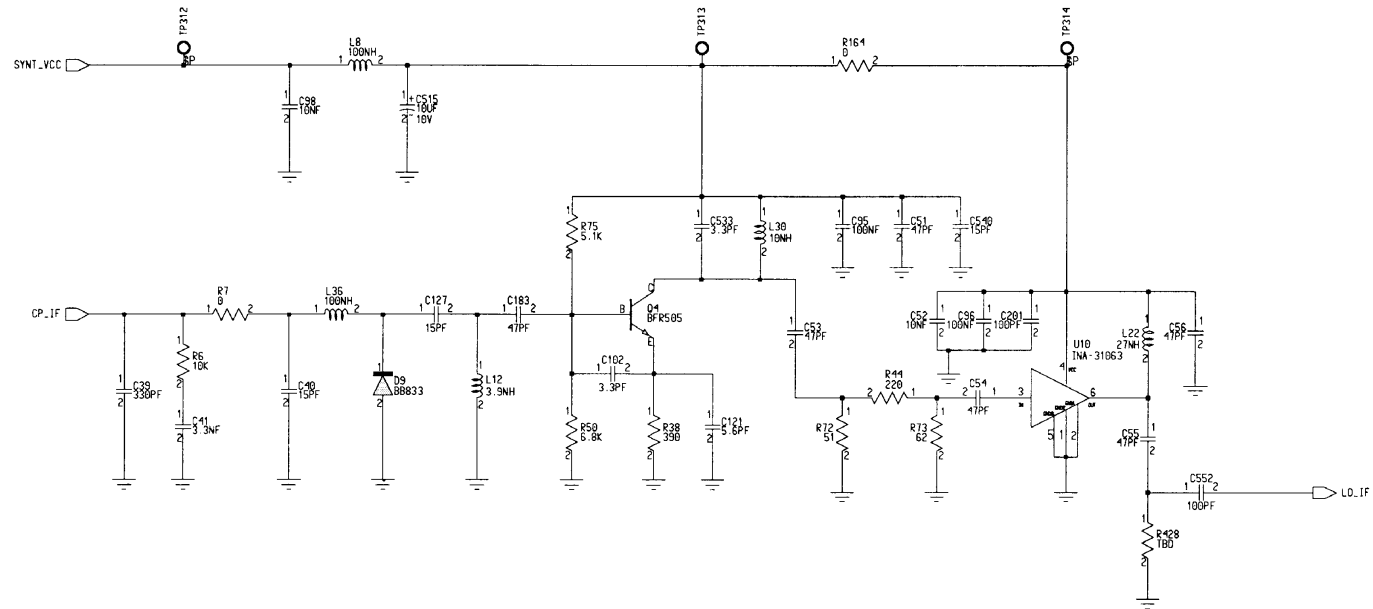


	Date	Changed Part	Changed By	Note
1				
2				
3				
4				
5				

Engineer:	BREEZECOM		
Drawn by:			
Rev'd:	TITLE: IF_VCO		Size: A3
DOC CTRL CHK:			8 1 6 A TL
MFG ENGR CHK:			

Changed by:	Date Changed:	Time Changed:	Rev'd:	Rev'd:	Rev'd:
shloni	13/2/2000	10:55:39 am	0A	0A	0A

Drawing Number: 8 1 6 A TL

Page: 20

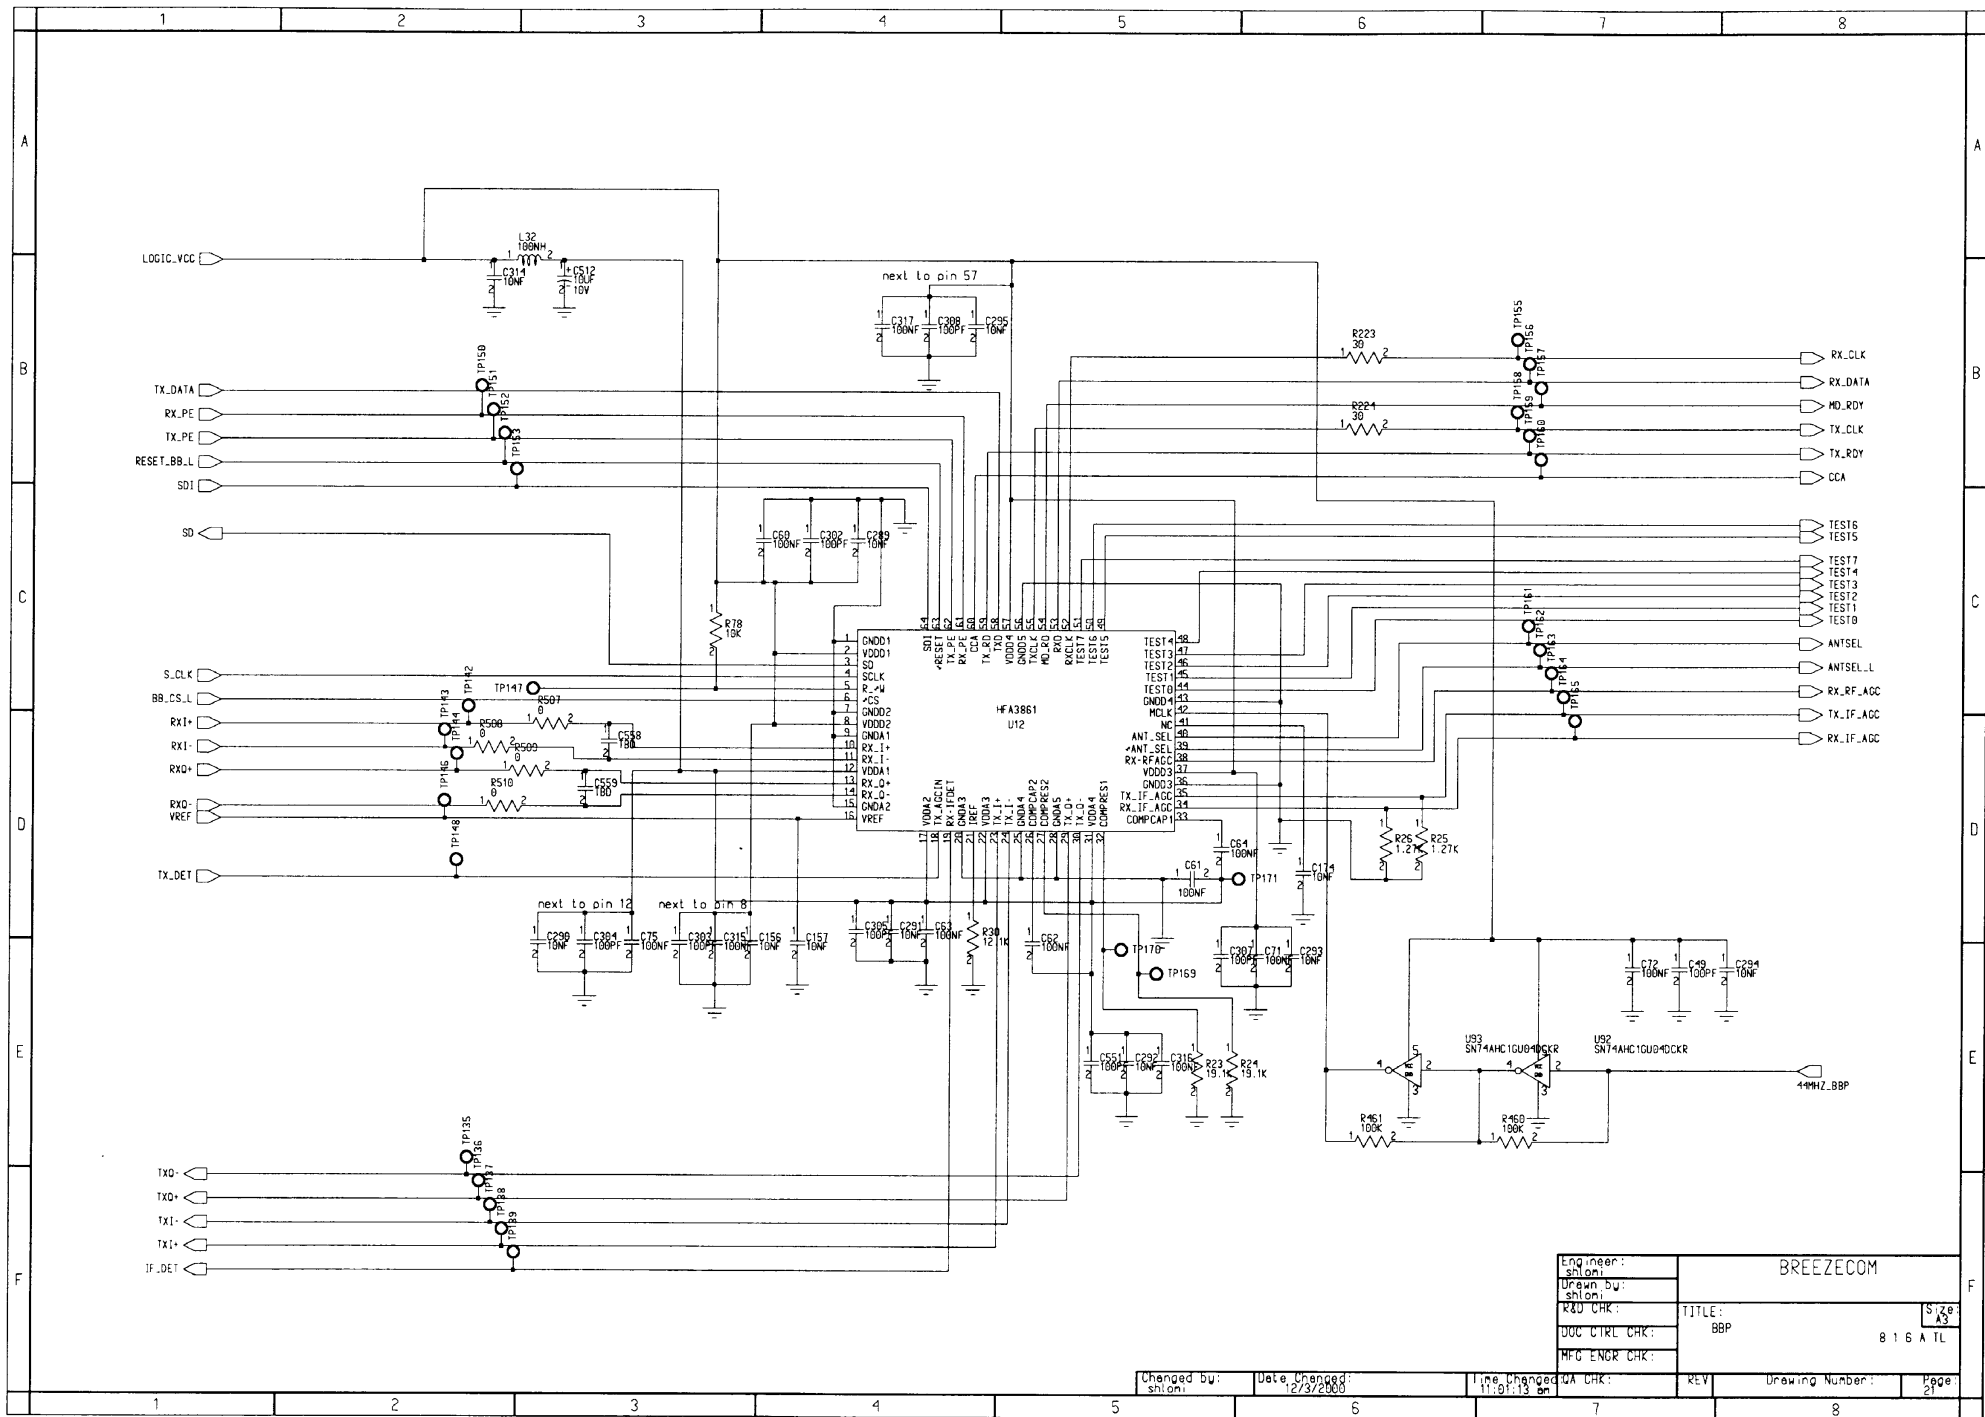

Engineer:	shlomi	BREEZECOM	
Drawn by:	shlomi		
REV	CHK:	TITLE:	Size
DDC	CHK:	BBP	A3
MFG	CHK:	8 1 6 A TL	

Changed by:	Date Changed:	Time Changed:	Rev	Drawing Number:	Page
shlomi	12/31/2000	11:59:13 am	1		21

